



**LEGEND**


— EXISTING

— NEW

- - - FUTURE

**NOTES:**

1. WATER SURFACE ELEVATIONS WITHIN EXISTING GRAVITY AND CARBON FILTER BUILDINGS MAY VARY DEPENDING ON TYPE OF FILTER SELECTED DURING DP #1 DESIGN.

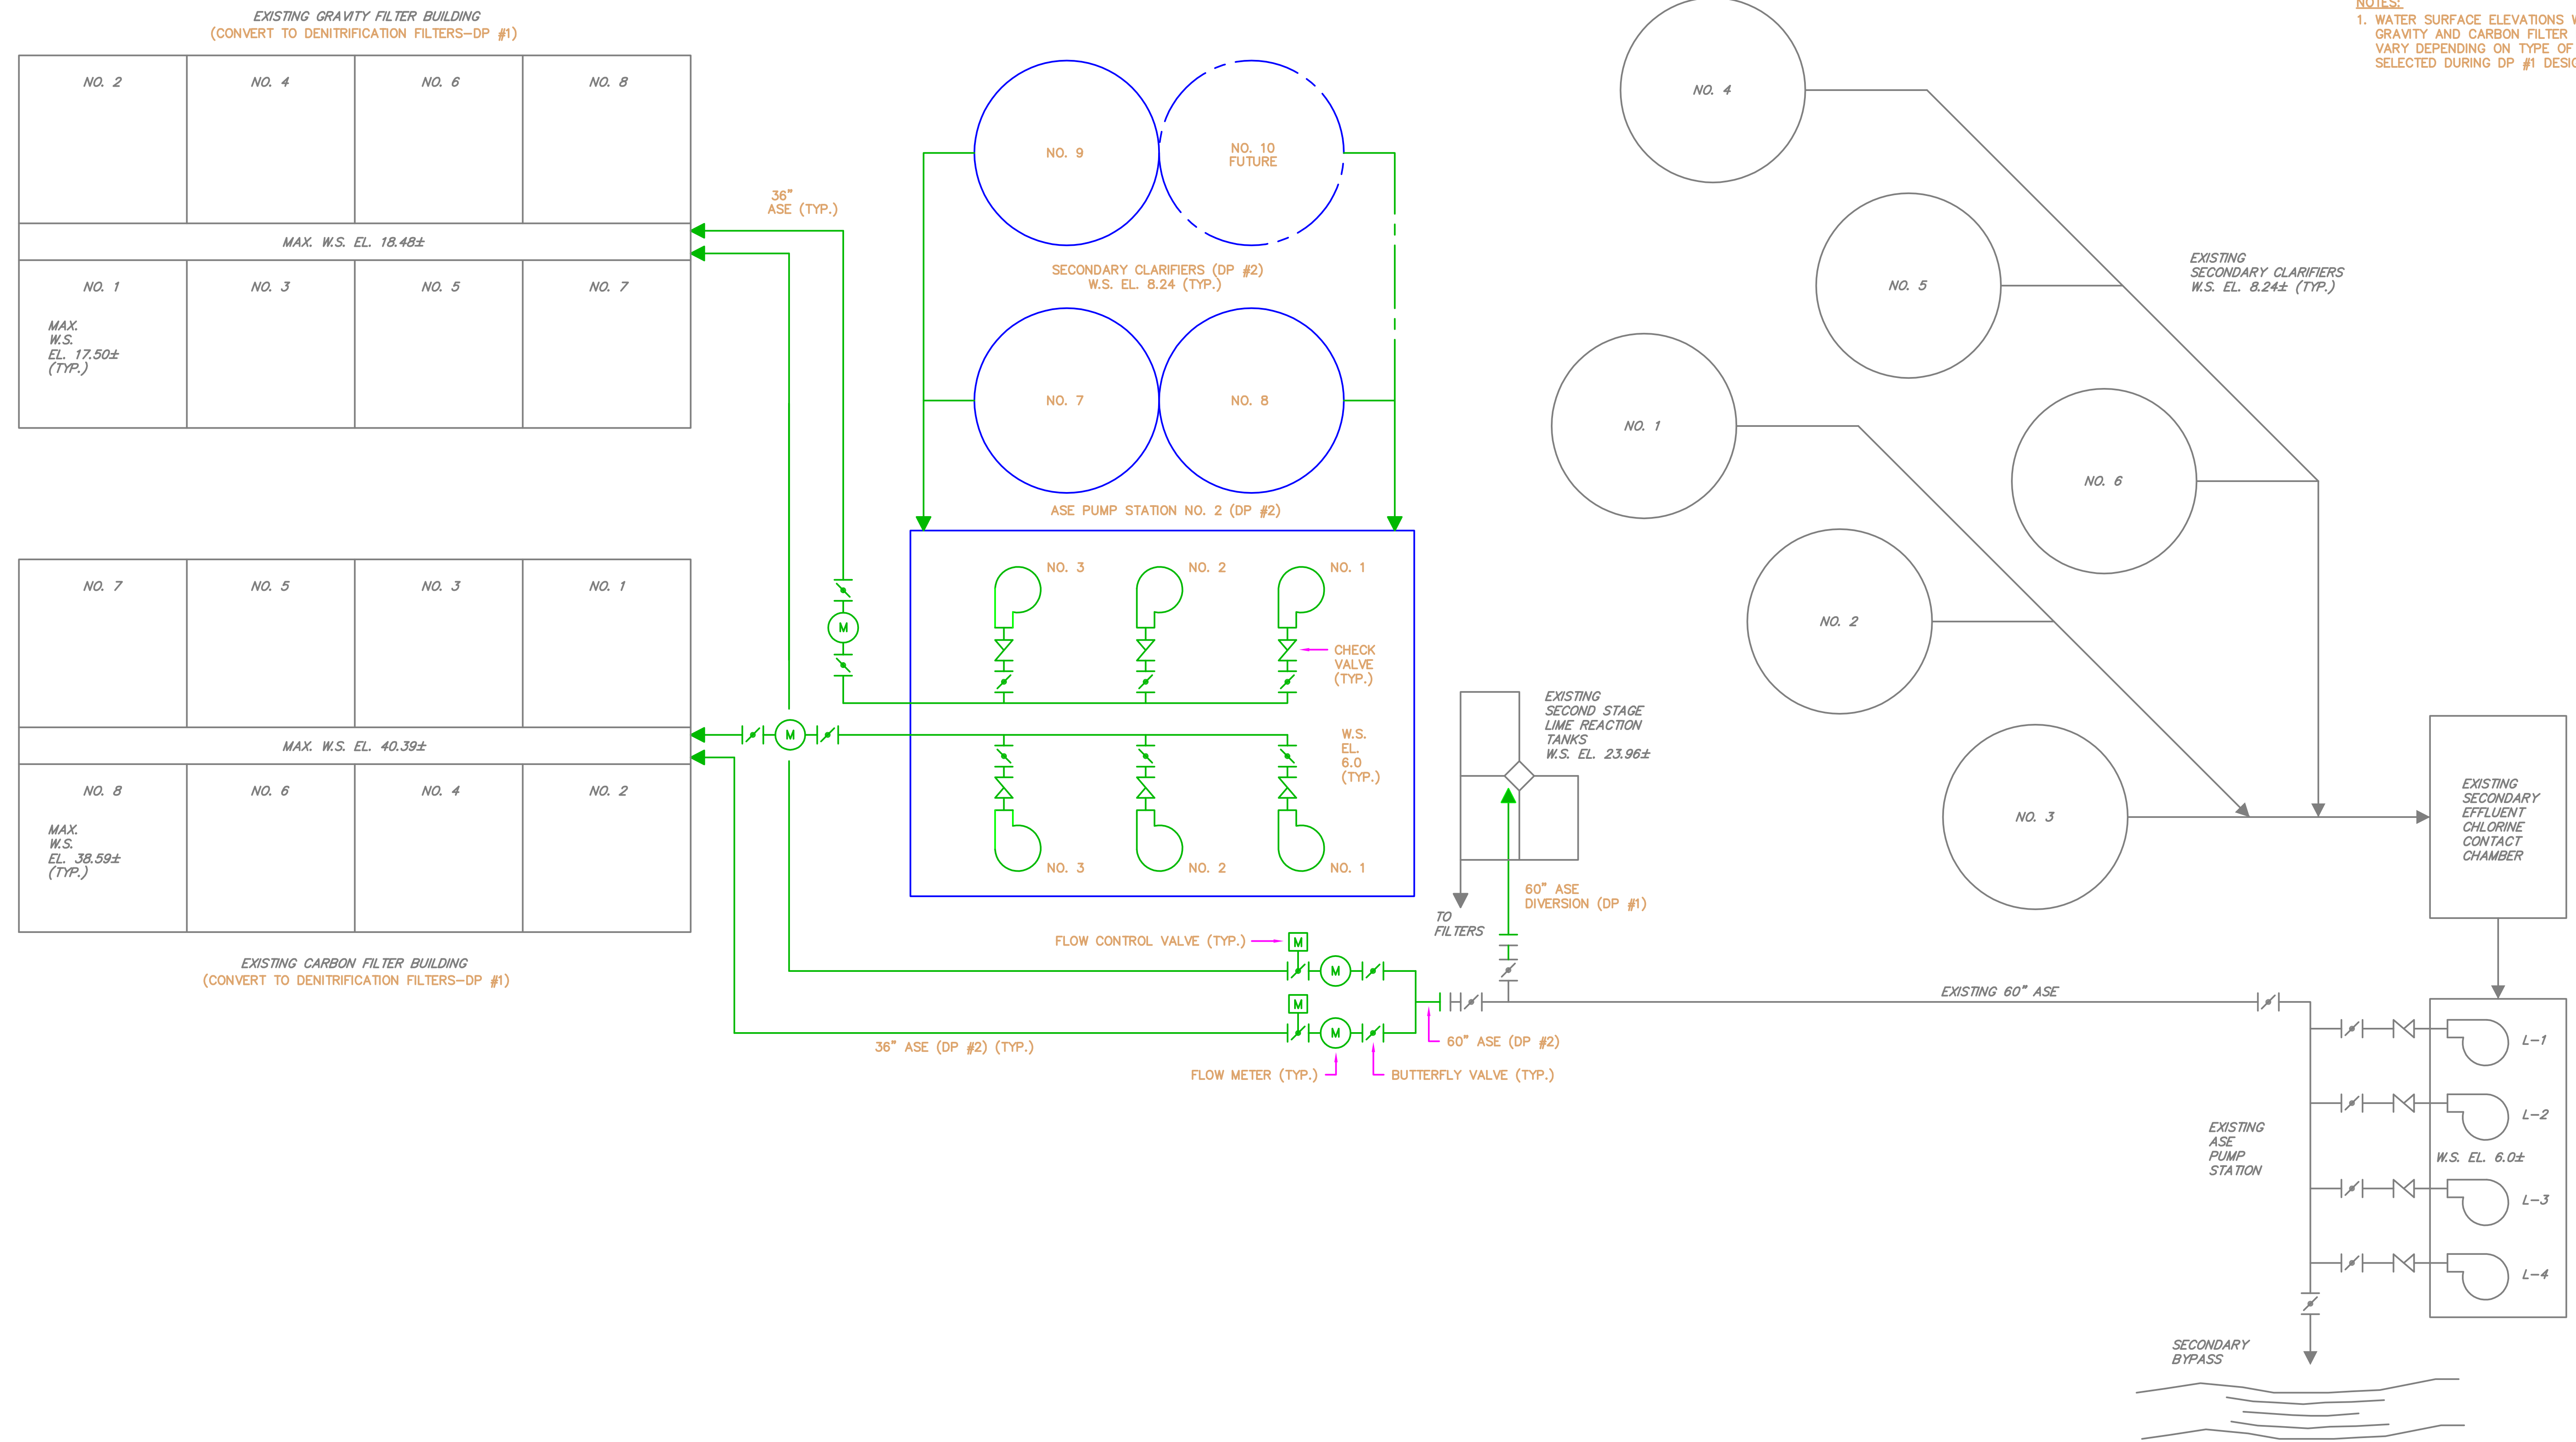

**PROCESS FLOW DIAGRAM**  
 NOT TO SCALE

DESIGNED	X
DRAWN	X
CHECKED	
PROJ. ENGR.	X
APPROVED	



ARLINGTON COUNTY  
 WATER POLLUTION CONTROL PLANT

MASTER PLAN 2001 UPDATE  
 PRELIMINARY STUDY, PHASE 7

ASE PUMPING SYSTEM  
 PROCESS FLOW DIAGRAM  
 DESIGN PACKAGE NO.2

THE SCALE BAR SHOWN BELOW MEASURES ONE INCH LONG ON THE ORIGINAL DRAWING.

DRAWING NUMBER  
**5C6-1**  
 SHEET X OF X